


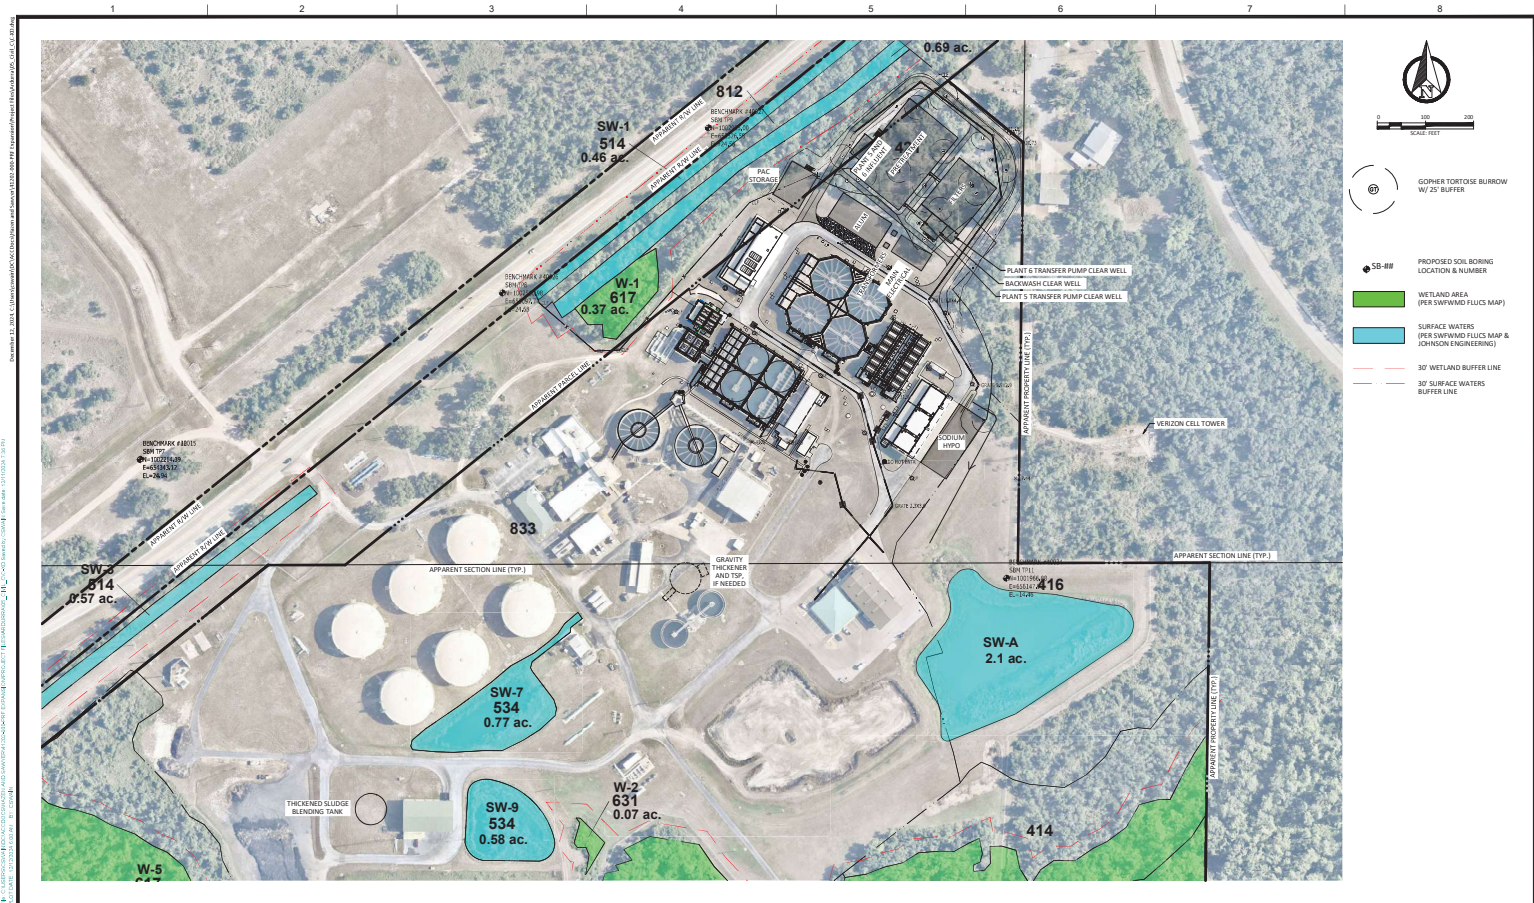

ARDURRA
CONSULTING SERVICES, INC.

4011 National Highway
One Manassas Center, Suite 300
Manassas, Florida 33409
Phone: (352) 888-4881
www.ardurra.com
License: 02010

ISSUE	DATE	DESCRIPTION
1	OCT 2024	INTERMEDIATE DESIGN

PROJECT MANAGER: R. COLEMAN, P.E.	
DESIGNED BY	
DRAWN BY	
CHECKED BY	
PROJECT NUMBER	41002-000-0010-00

PRELIMINARY
NOT FOR
CONSTRUCTION
OR
RECORDING

PEACE RIVER REGIONAL
(PRF) PROJECT
DESOTO COUNTY, FLORIDA
PRF EXPANSION

PRELIMINARY SITE PLAN

FILENAME: ARDURRA\001_001-001.dwg
SCALE: AS SHOWN

SHEET
EXH-01